

SMALLWOOD STATE PARK
REPLACE PAVILION #2
CHARLES COUNTY, MARYLAND
PROJECT NO. EC25-09022-08

FOR THE
STATE OF MARYLAND
DEPARTMENT OF NATURAL RESOURCES
ENGINEERING AND CONSTRUCTION

TAWES STATE OFFICE BUILDING D-3
580 TAYLOR AVENUE
ANNAPOLIS, MARYLAND 21401-2351

DEPARTMENT OF NATURAL RESOURCES
JOSH KURTZ, SECRETARY

DEPARTMENT OF GENERAL SERVICES
ATIF CHAUDHRY., SECRETARY


STATE OF MARYLAND, BOARD OF PUBLIC WORKS
WES MOORE, GOVERNOR
BROOKE E. LIERMAN, COMPTROLLER
DERECK E. DAVIS, TREASURER



A VICINITY MAP
NOT TO SCALE




B LOCATION MAP
NOT TO SCALE

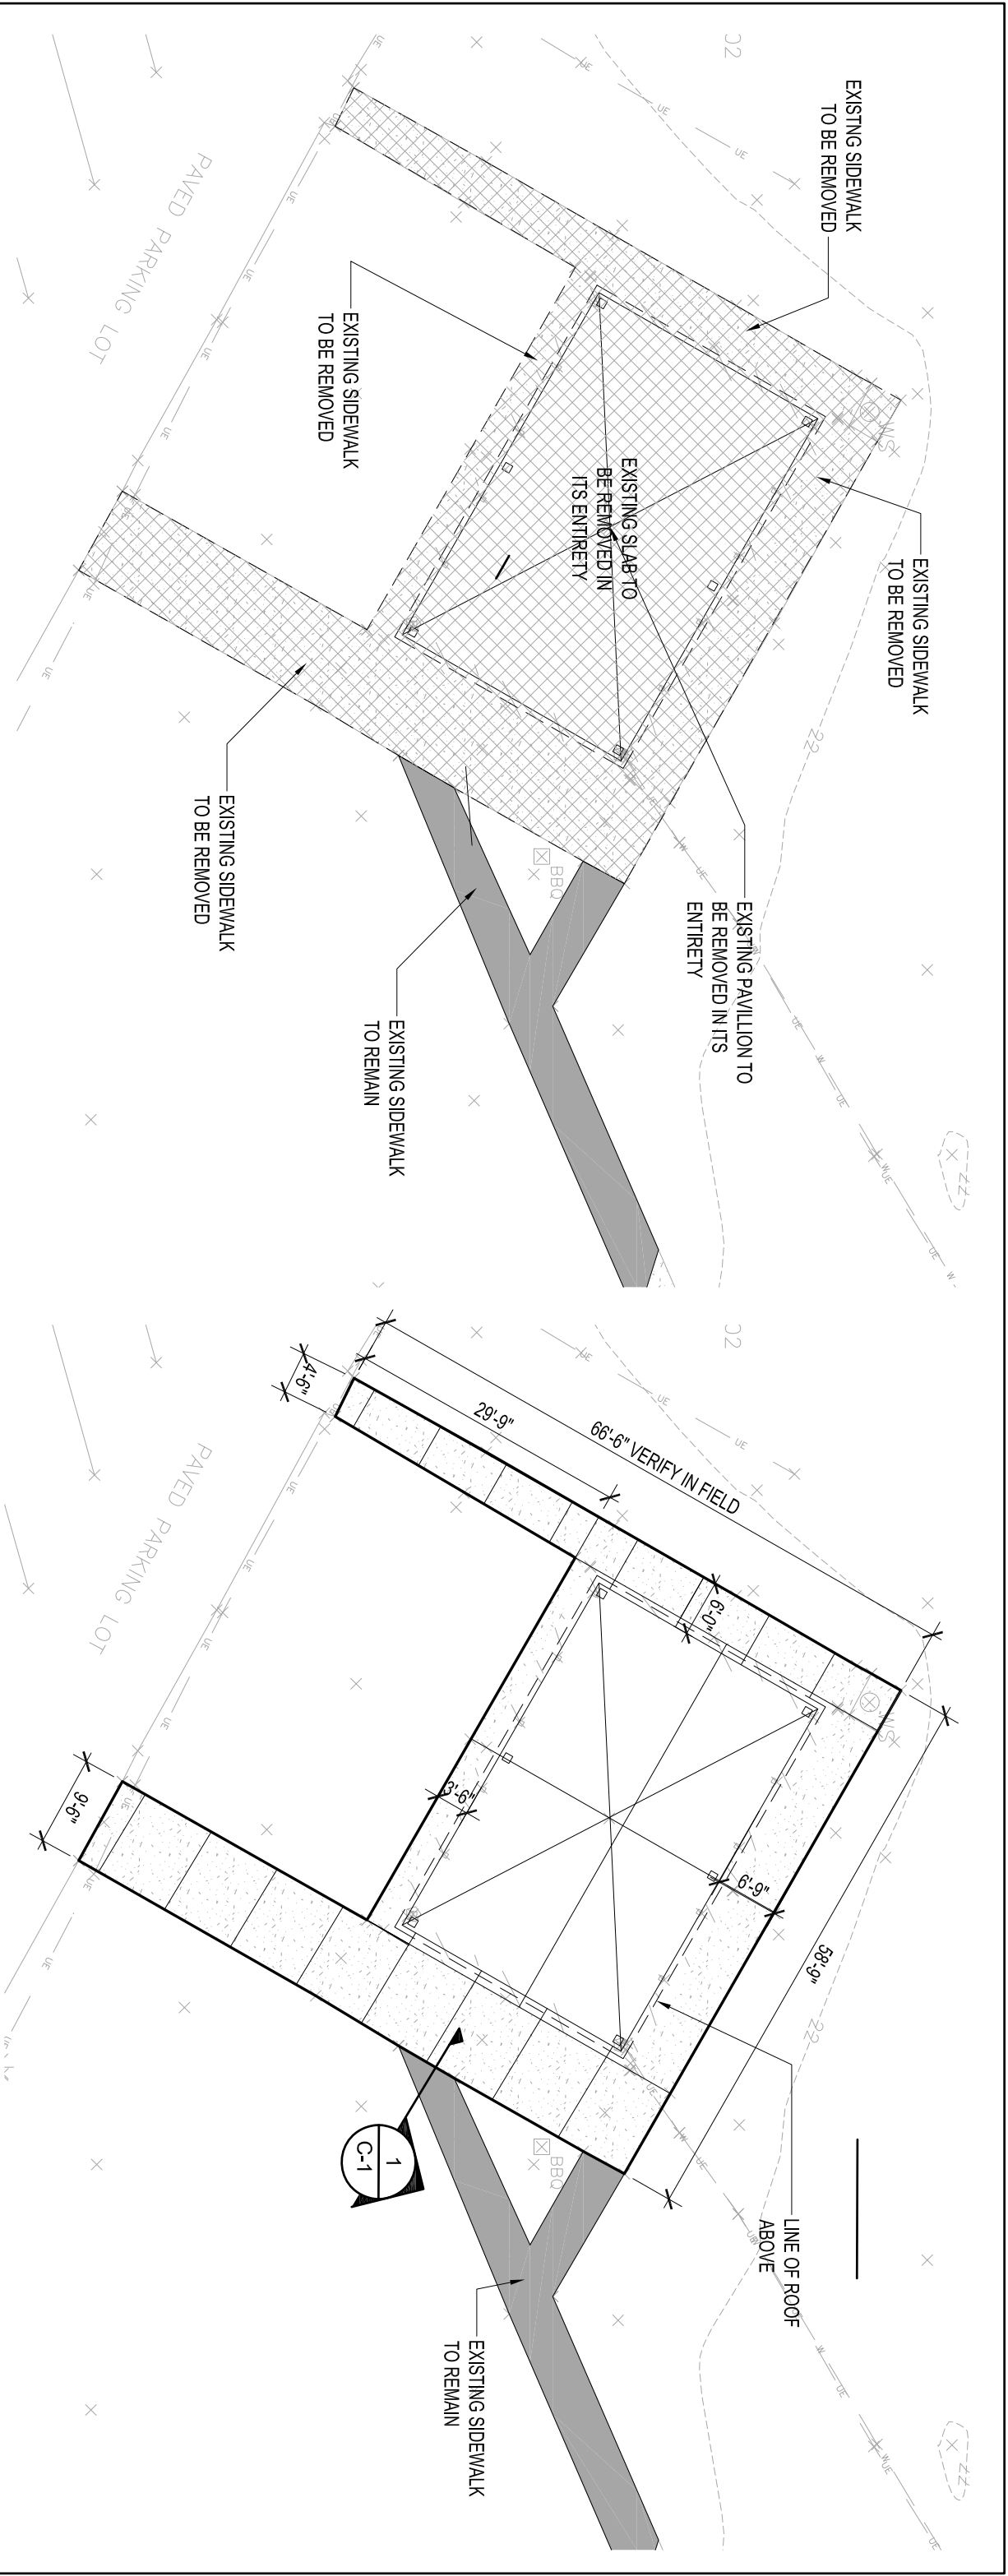


A SITE PLAN - DEMOLITION

NOT TO SCALE

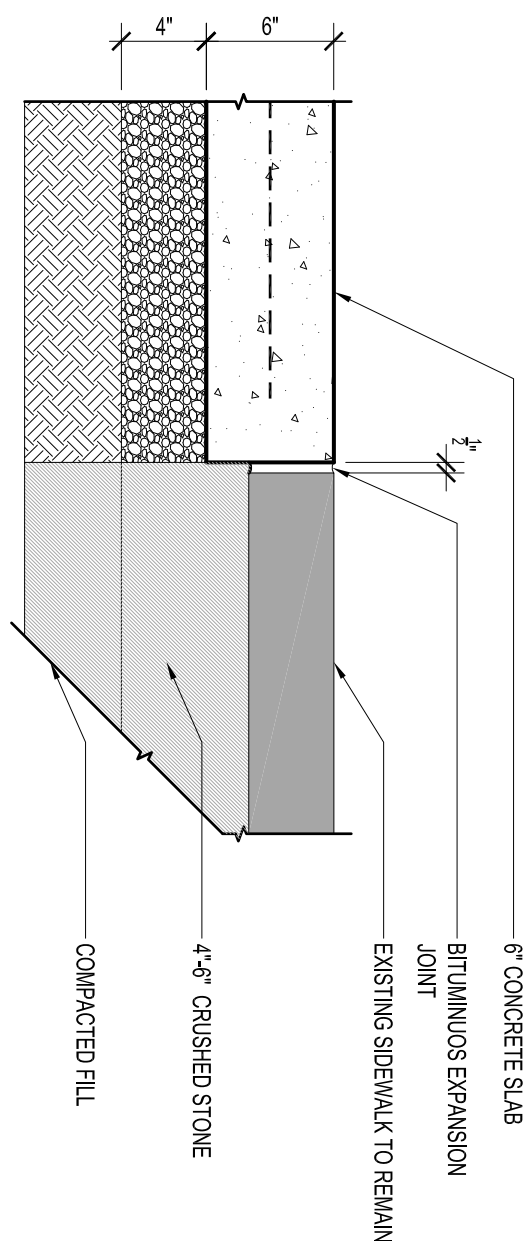





B SITE PLAN - NEW WORK

NOT TO SCALE

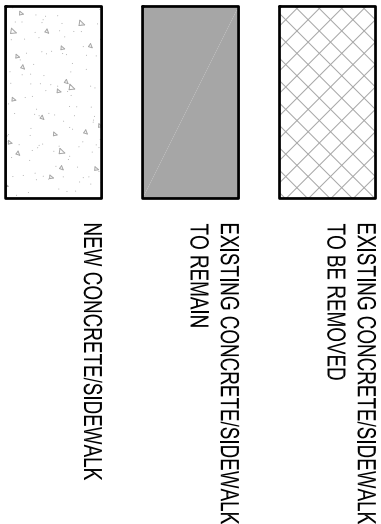

1 SIDEWALK\SLAB

NOT TO SCALE

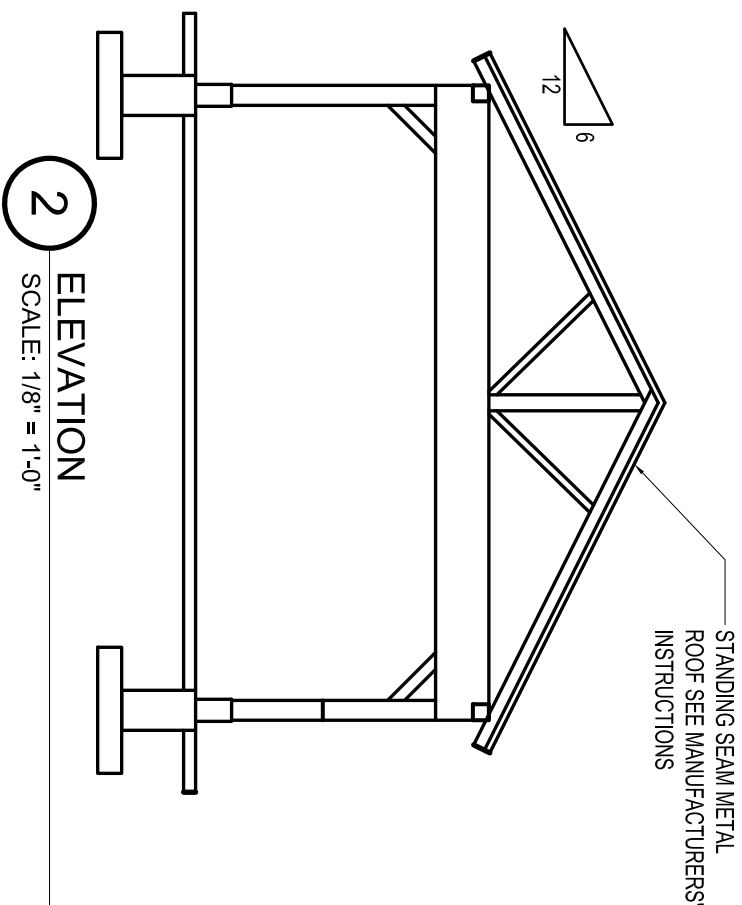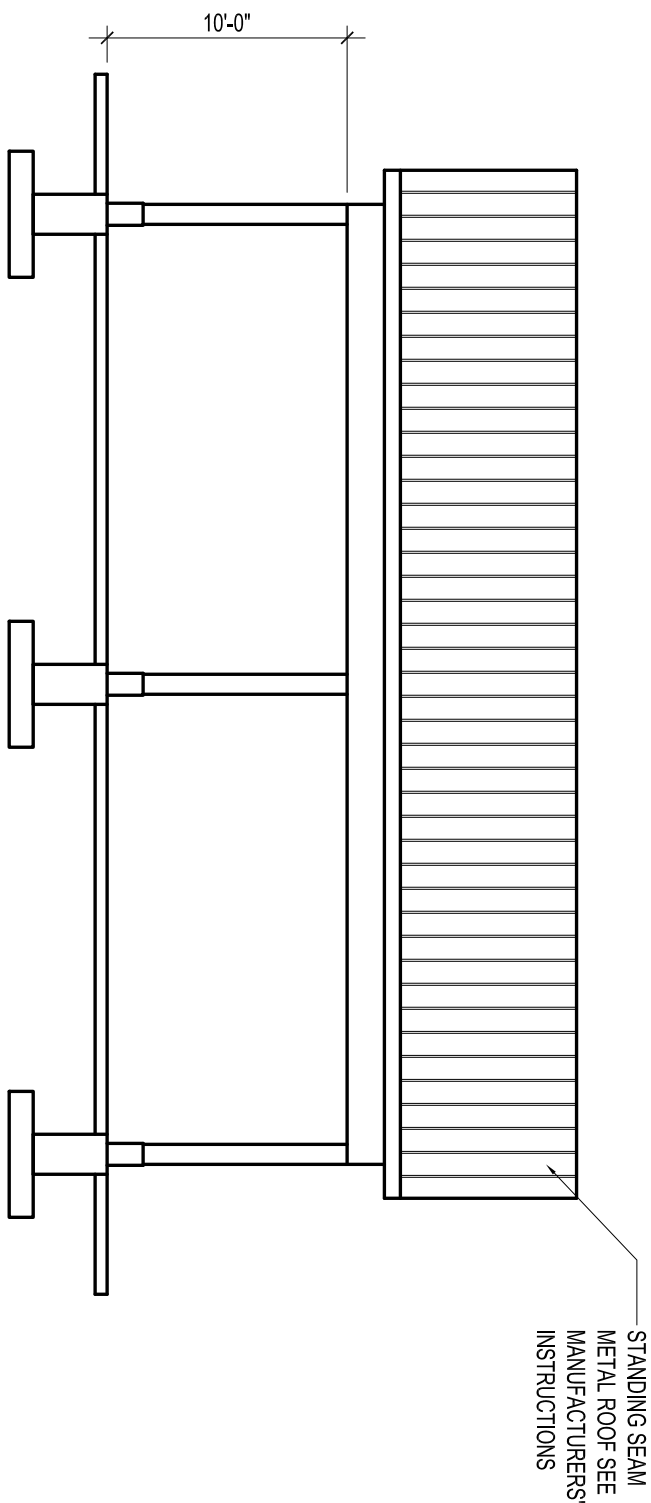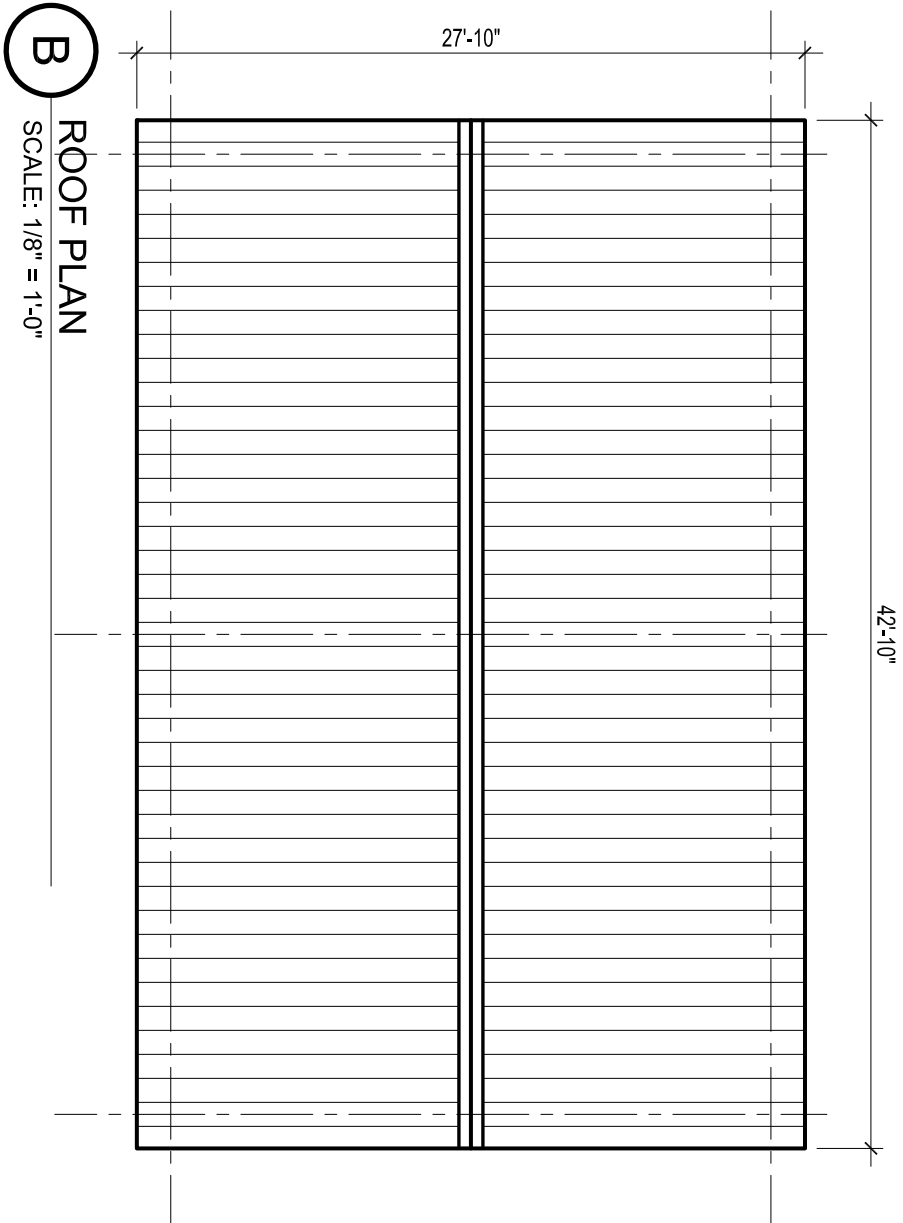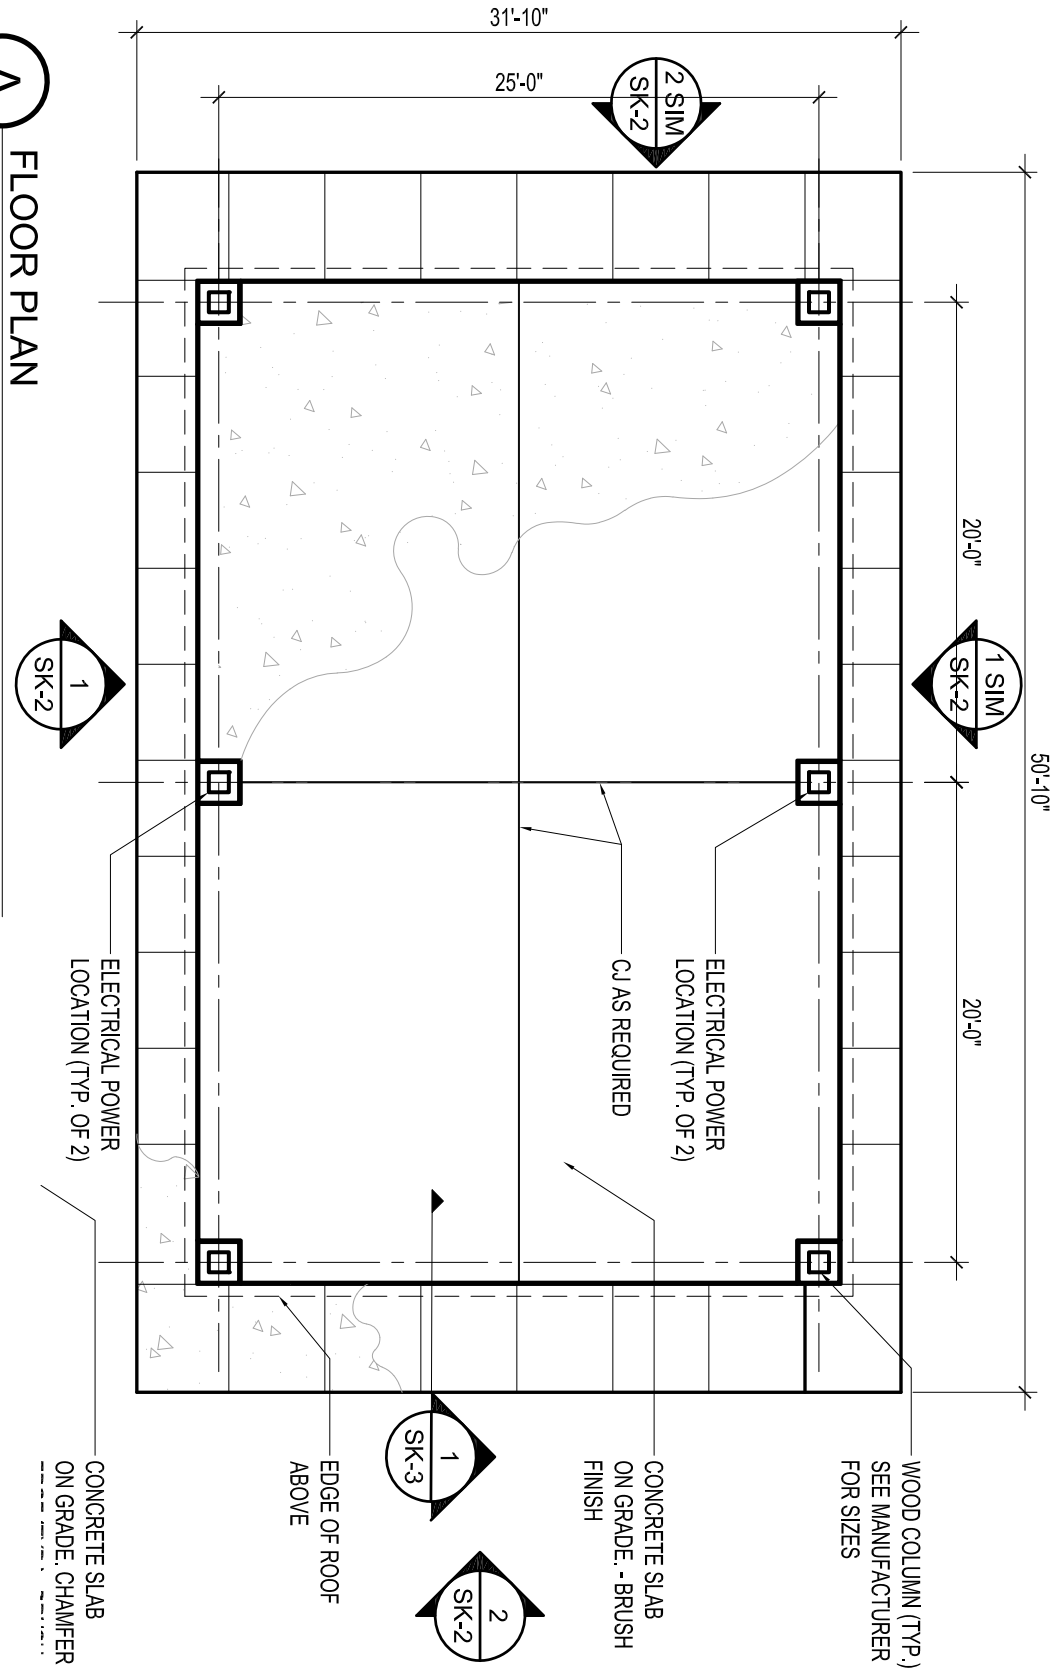


SK-2


PLANS AND ELEVATIONS
SMALLWOOD STATE PARK
REPLACE PAVILLION #2
CHARLES COUNTY, MARYLAND

STATE OF MARYLAND
DEPARTMENT OF NATURAL RESOURCES
ENGINEERING AND CONSTRUCTION
MATAPEAKE MARINE TERMINAL
QUEEN ANNES COUNTY, MARYLAND



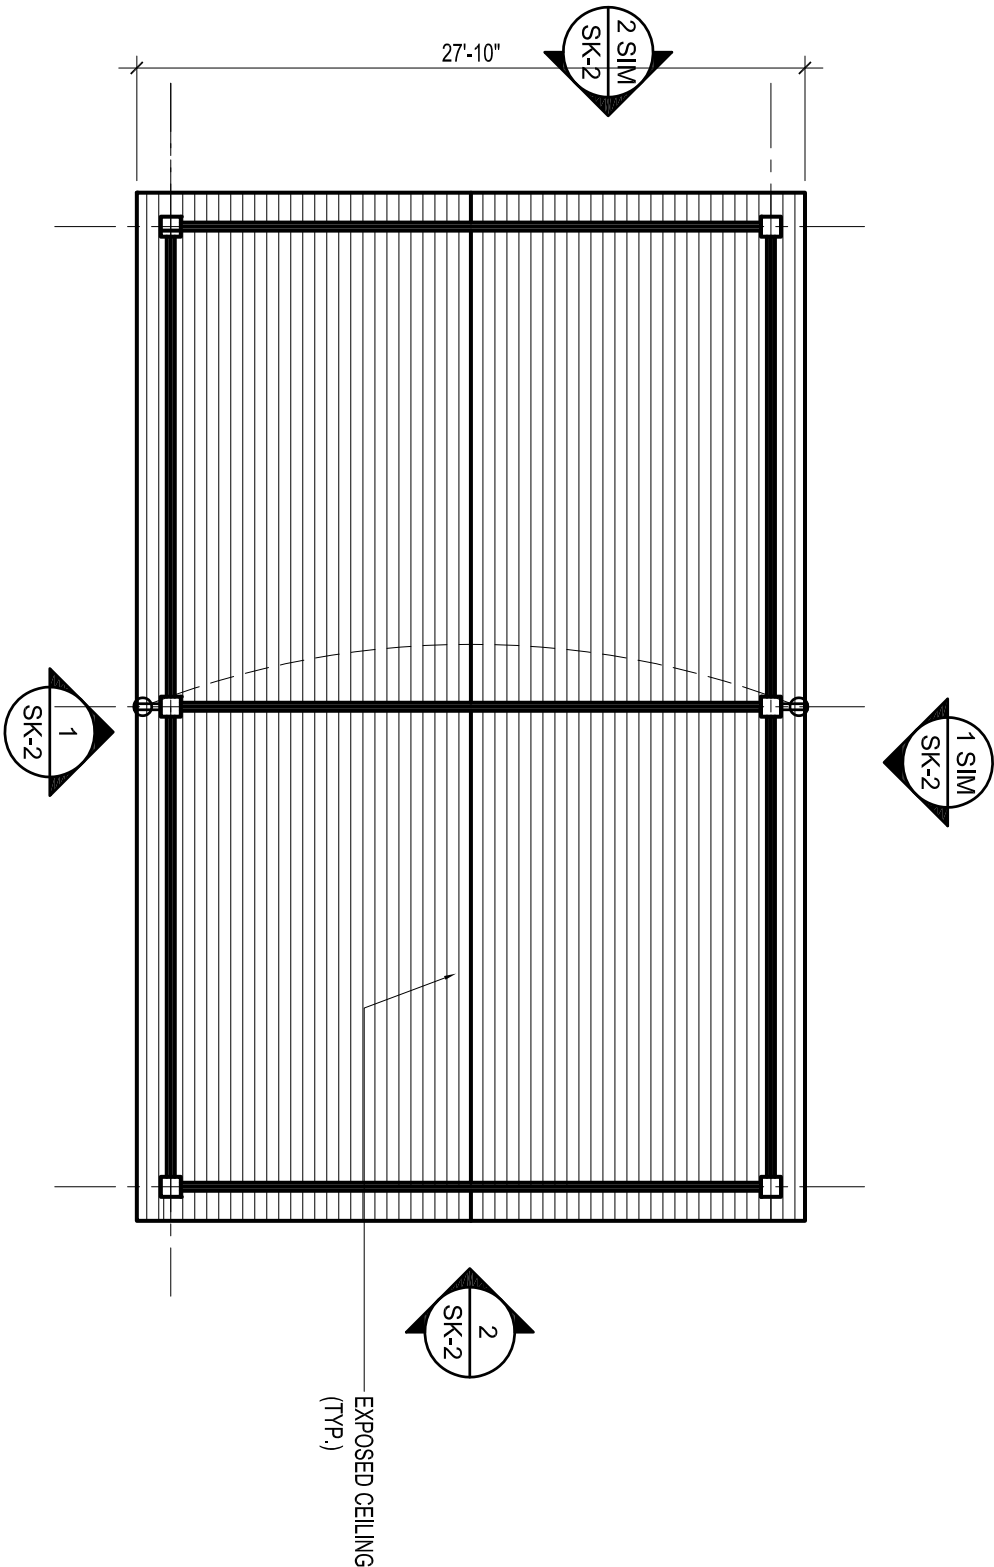

A ELECTRICAL OUTLET PLAN
SCALE: 1/8" = 1'-0"

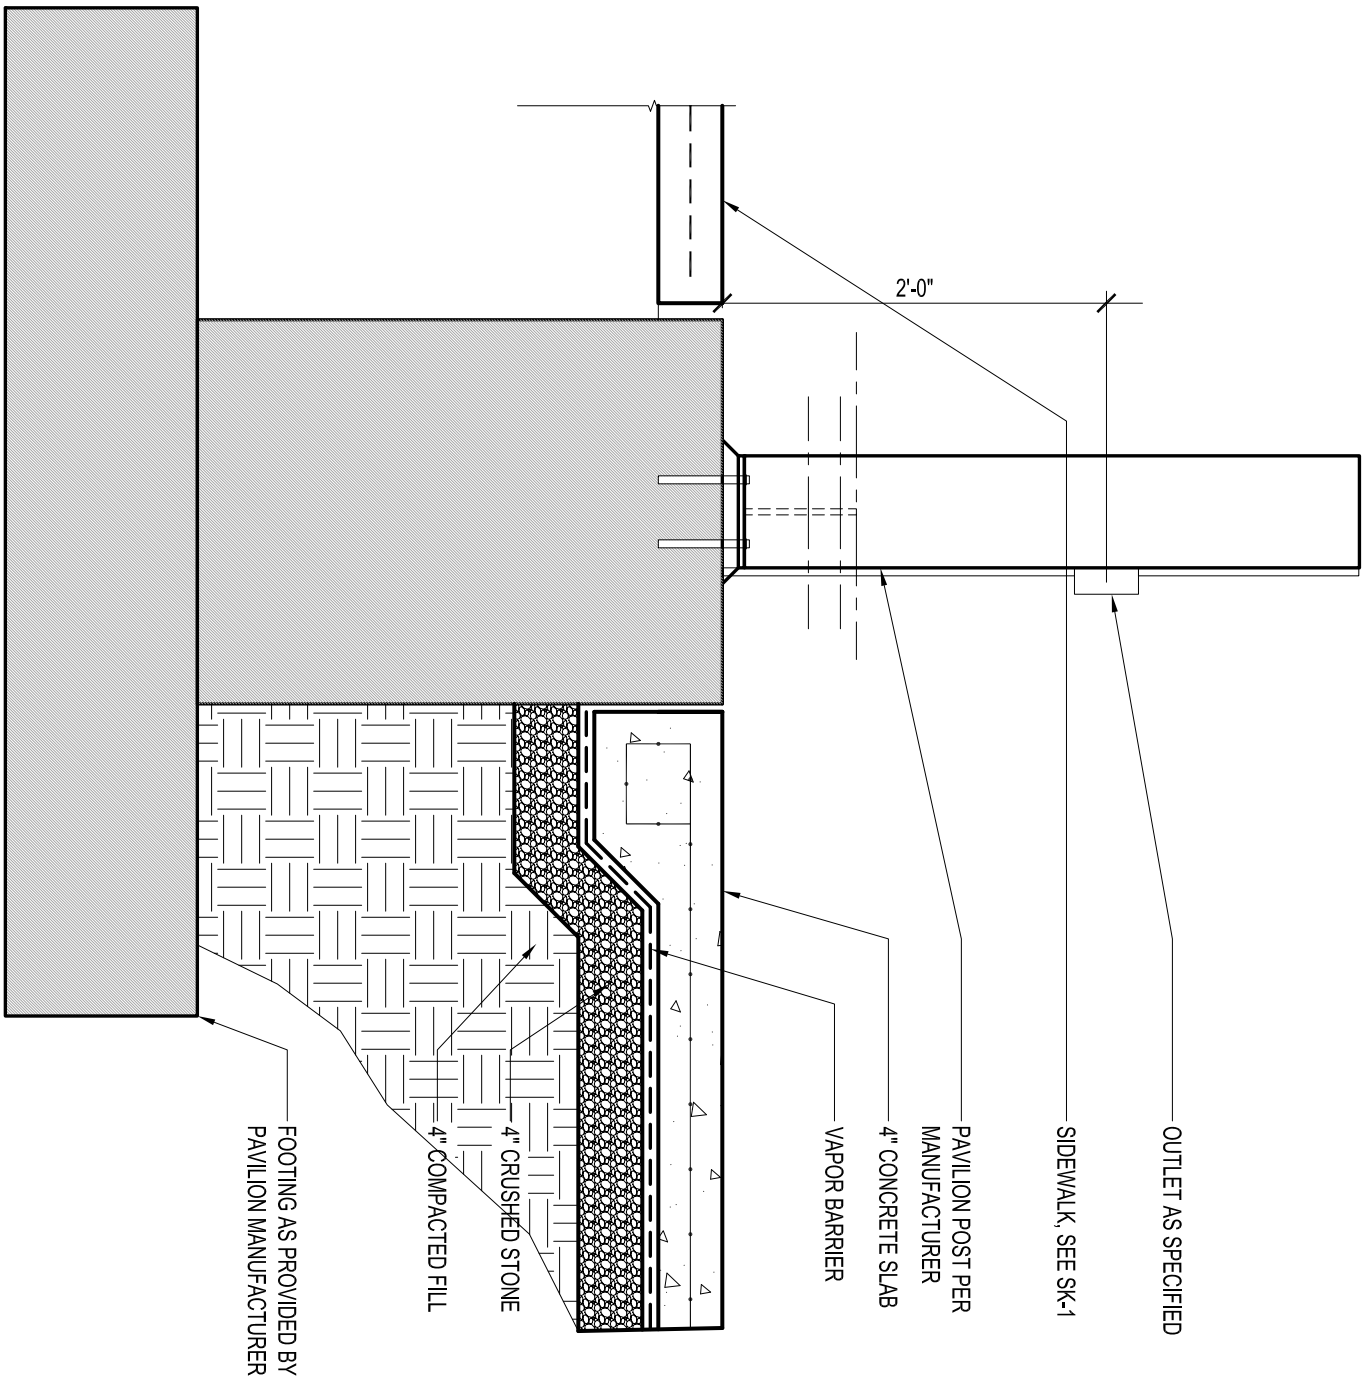

1 SLAB DETAIL AT FOOTING
SCALE: 1" = 1'-0"

SK-3

ELECTRICAL PLAN AND DETAIL
SMALLWOOD STATE PARK
REPLACE PAVILLION #2
CHARLES COUNTY, MARYLAND



STATE OF MARYLAND
DEPARTMENT OF NATURAL RESOURCES
ENGINEERING AND CONSTRUCTION
MATAPEAKE MARINE TERMINAL
QUEEN ANNE'S COUNTY, MARYLAND